


AIR DISTRIBUTION SCHEDULE				
MARK	DESCRIPTION	KRUEGER MODEL	PANEL SIZE	REMARKS
C	TITUS 7272RL 4" SUPPLY AIR REGISTER SEE FLOOR PLAN FOR SIZE.	890-V-DBD	SEE FLOOR PLAN	1,2,3

1. STEEL, FINISH AND BORDER SHALL MATCH CEILING. SEE ARCHITECT DRAWING FOR THE TYPE OF CEILING.
2. MANUAL VOLUME DAMPER.
3. FACTORY INSULATED DIFFUSER AT UNCONDITIONED AREA OR NO RETURN AIR PLENUM.

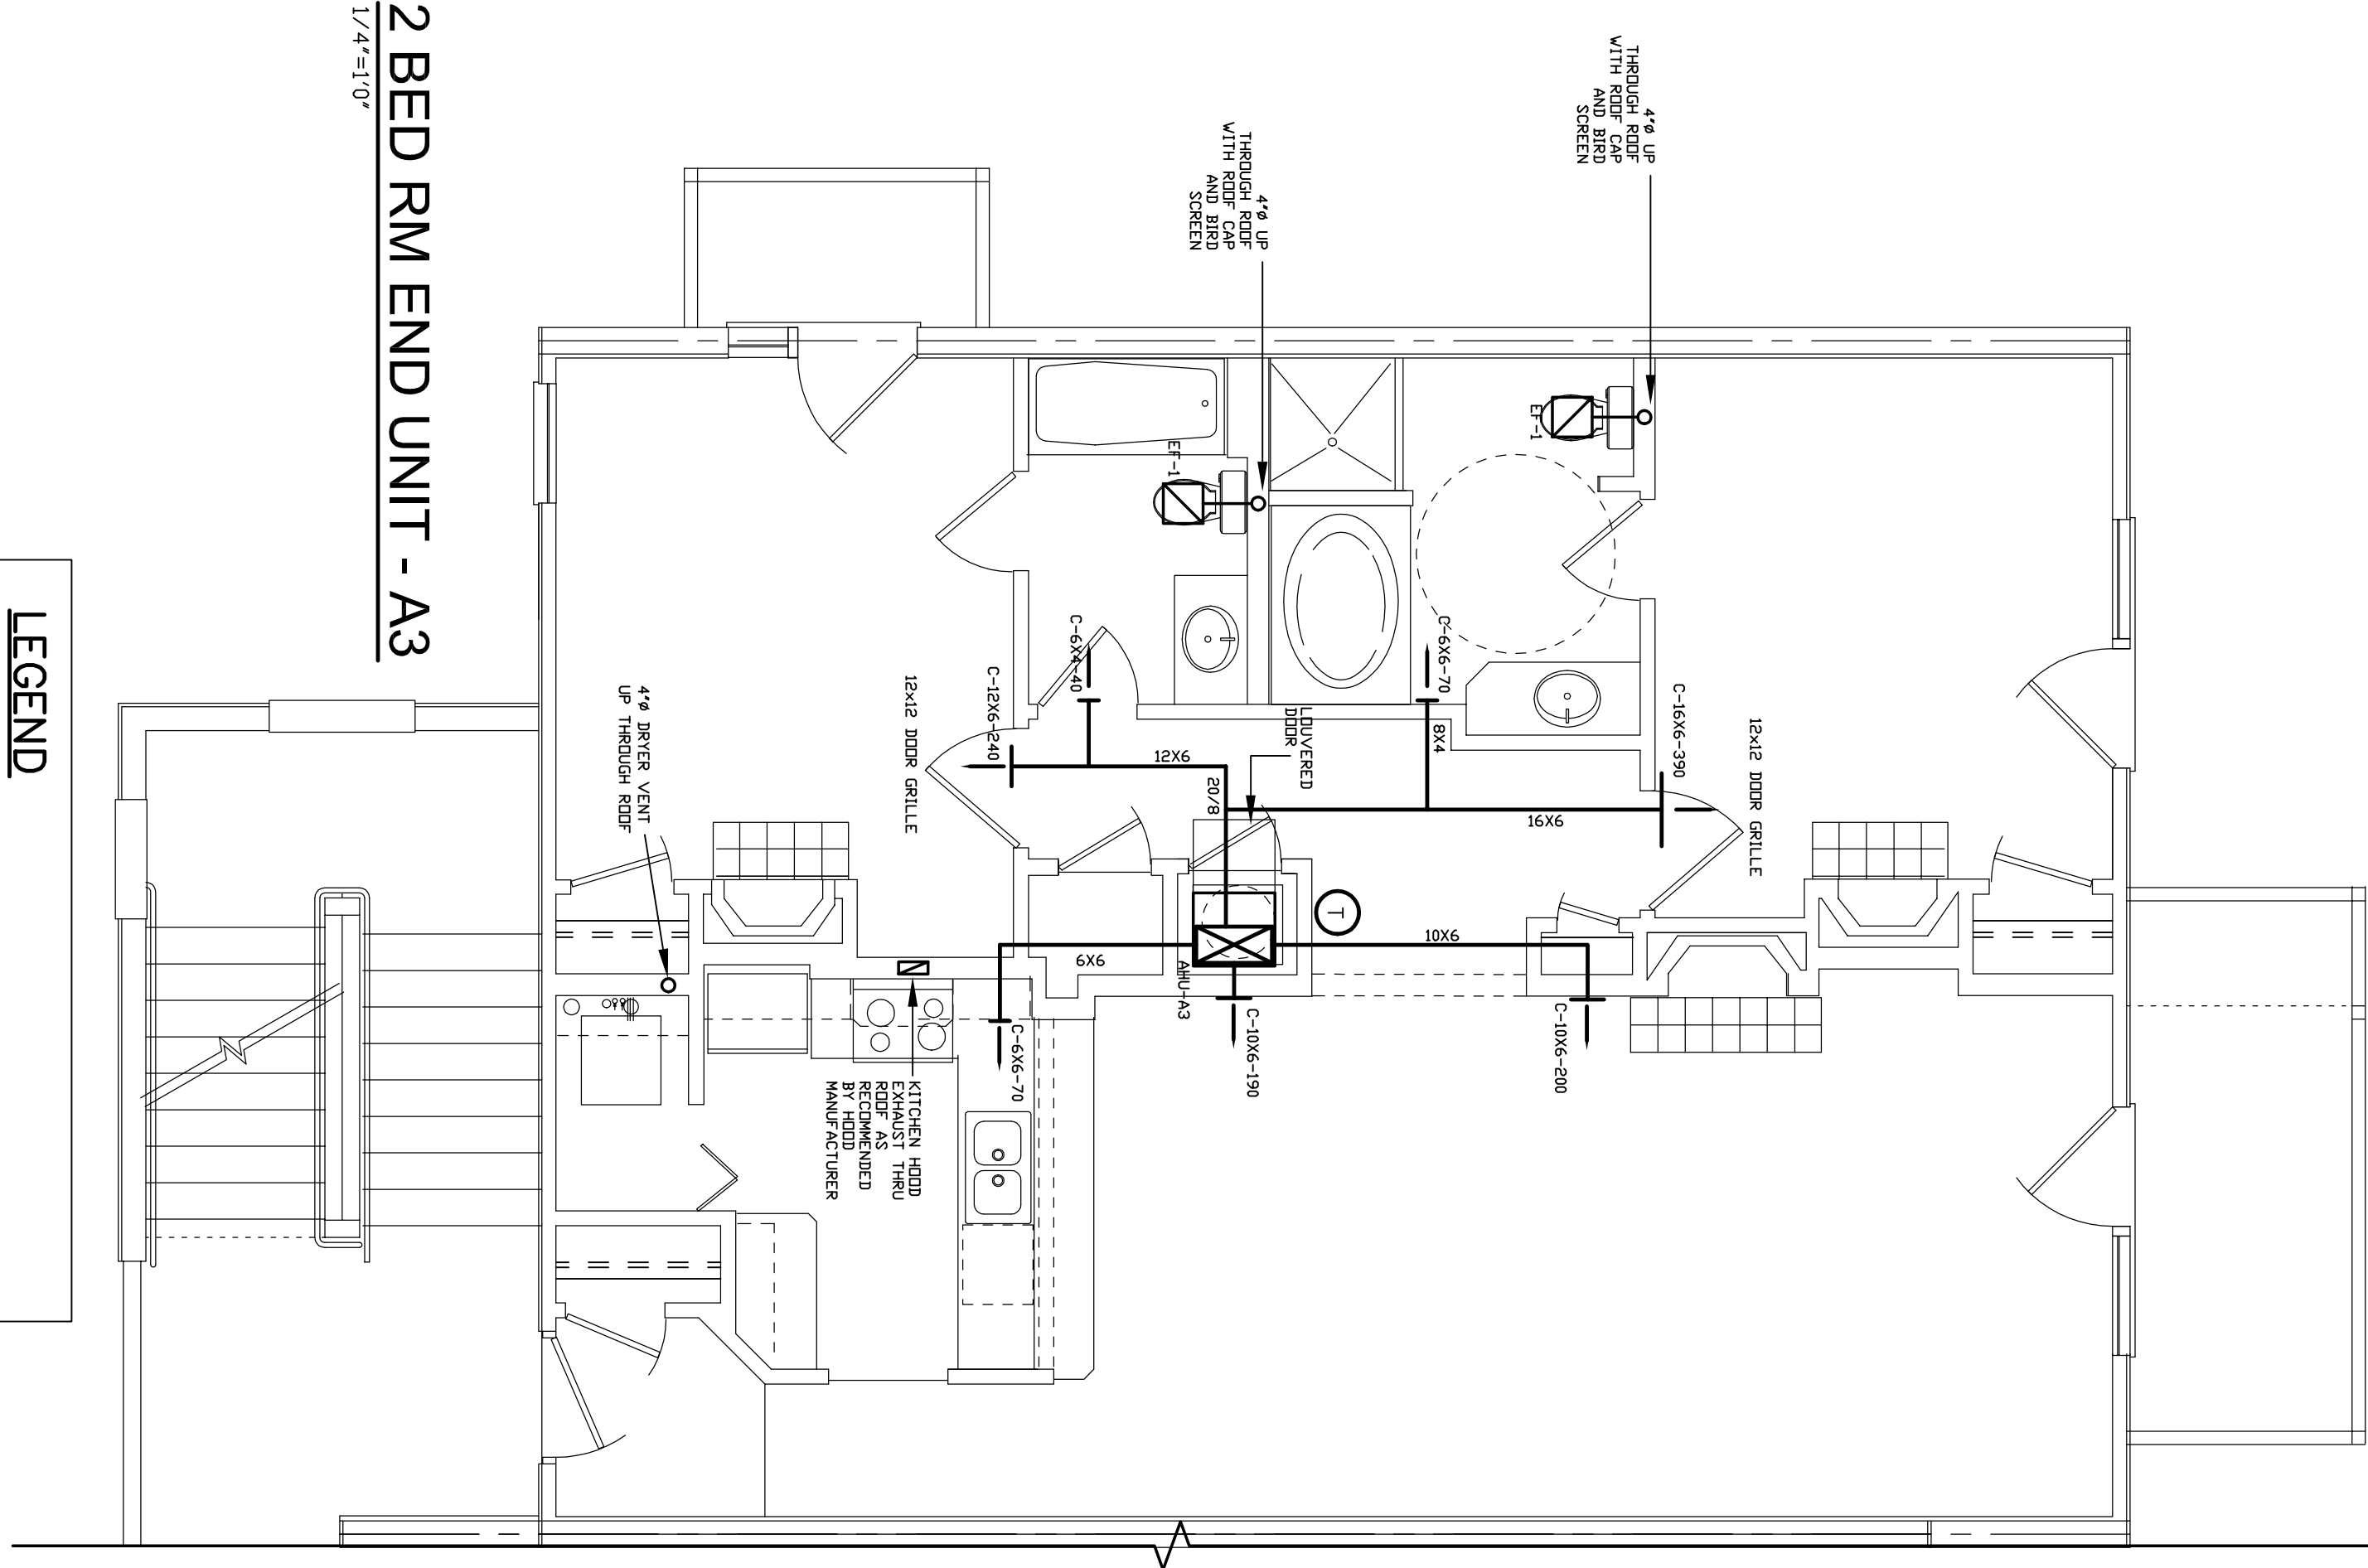


LEGEND

① THERMOSTAT (PROGRAMMABLE)


A-8-100-CTM NECK SIZE AIR DISTRIBUTION DEVICE SEE SCHEDULE.

MVD MANUAL VOLUME DAMPER


CONTINUOUS LINE INDICATES NEW DUCTWORK

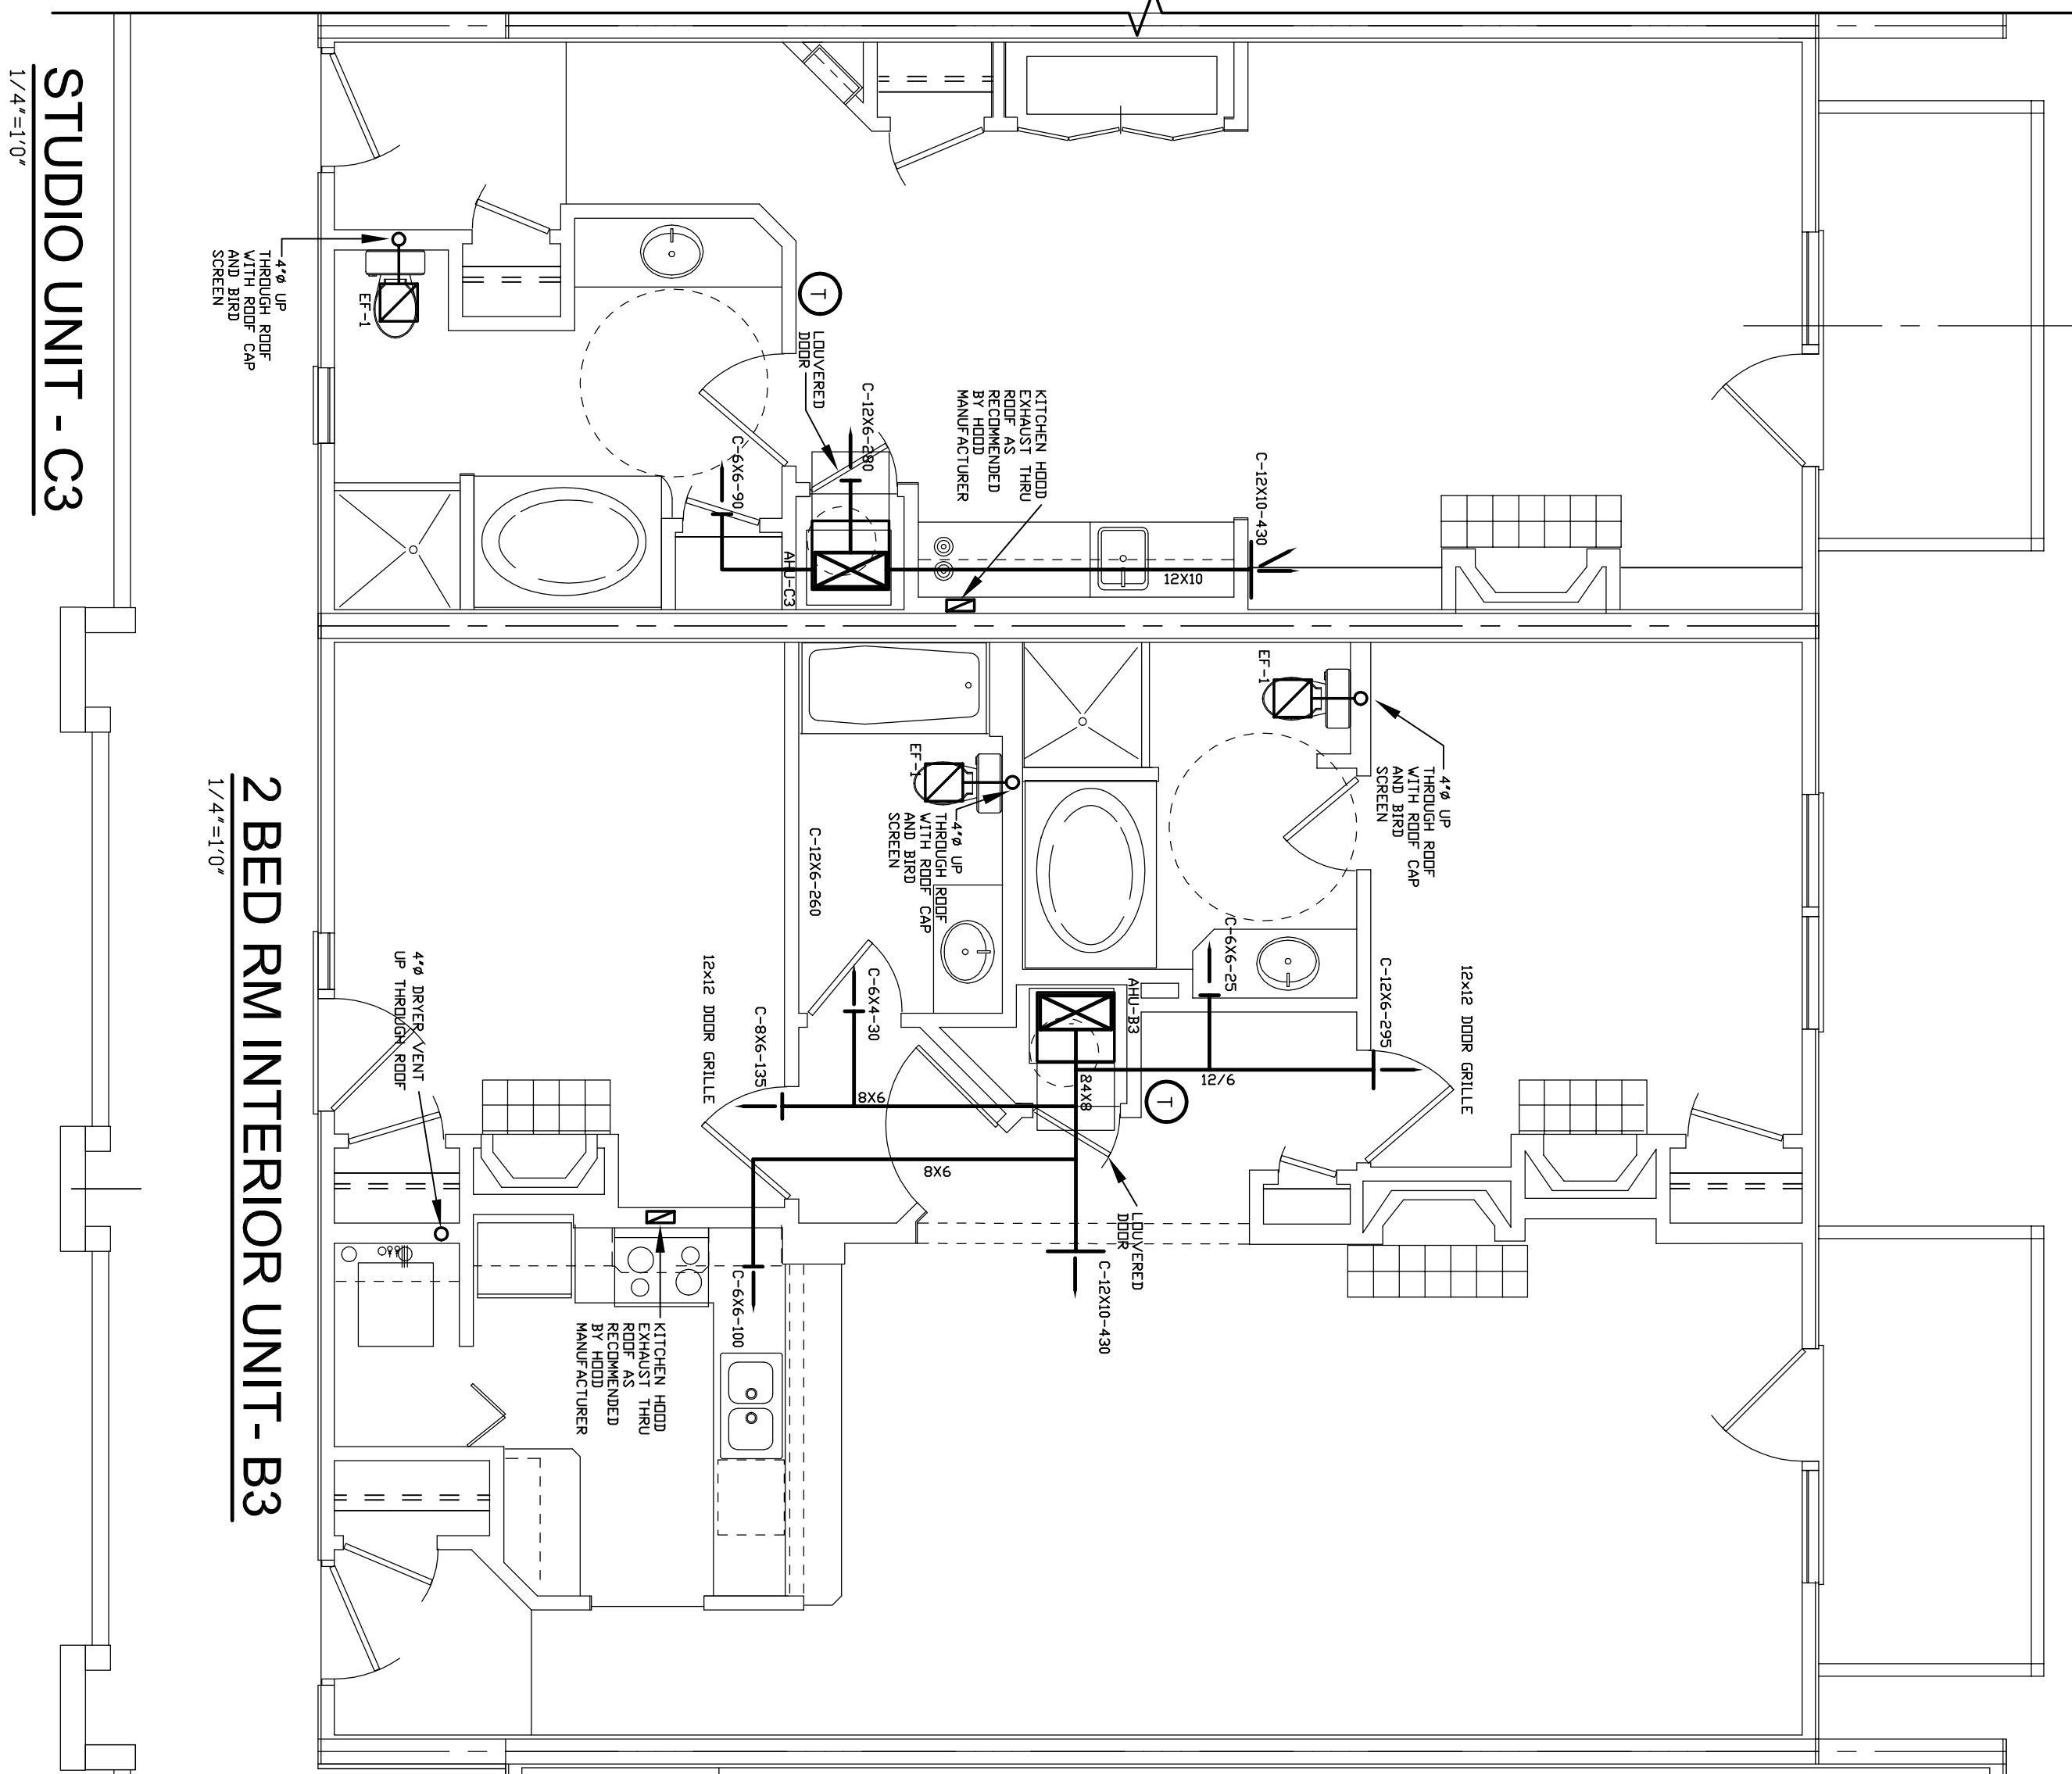

STUDIO UNIT - C3
1/4"=1'0"

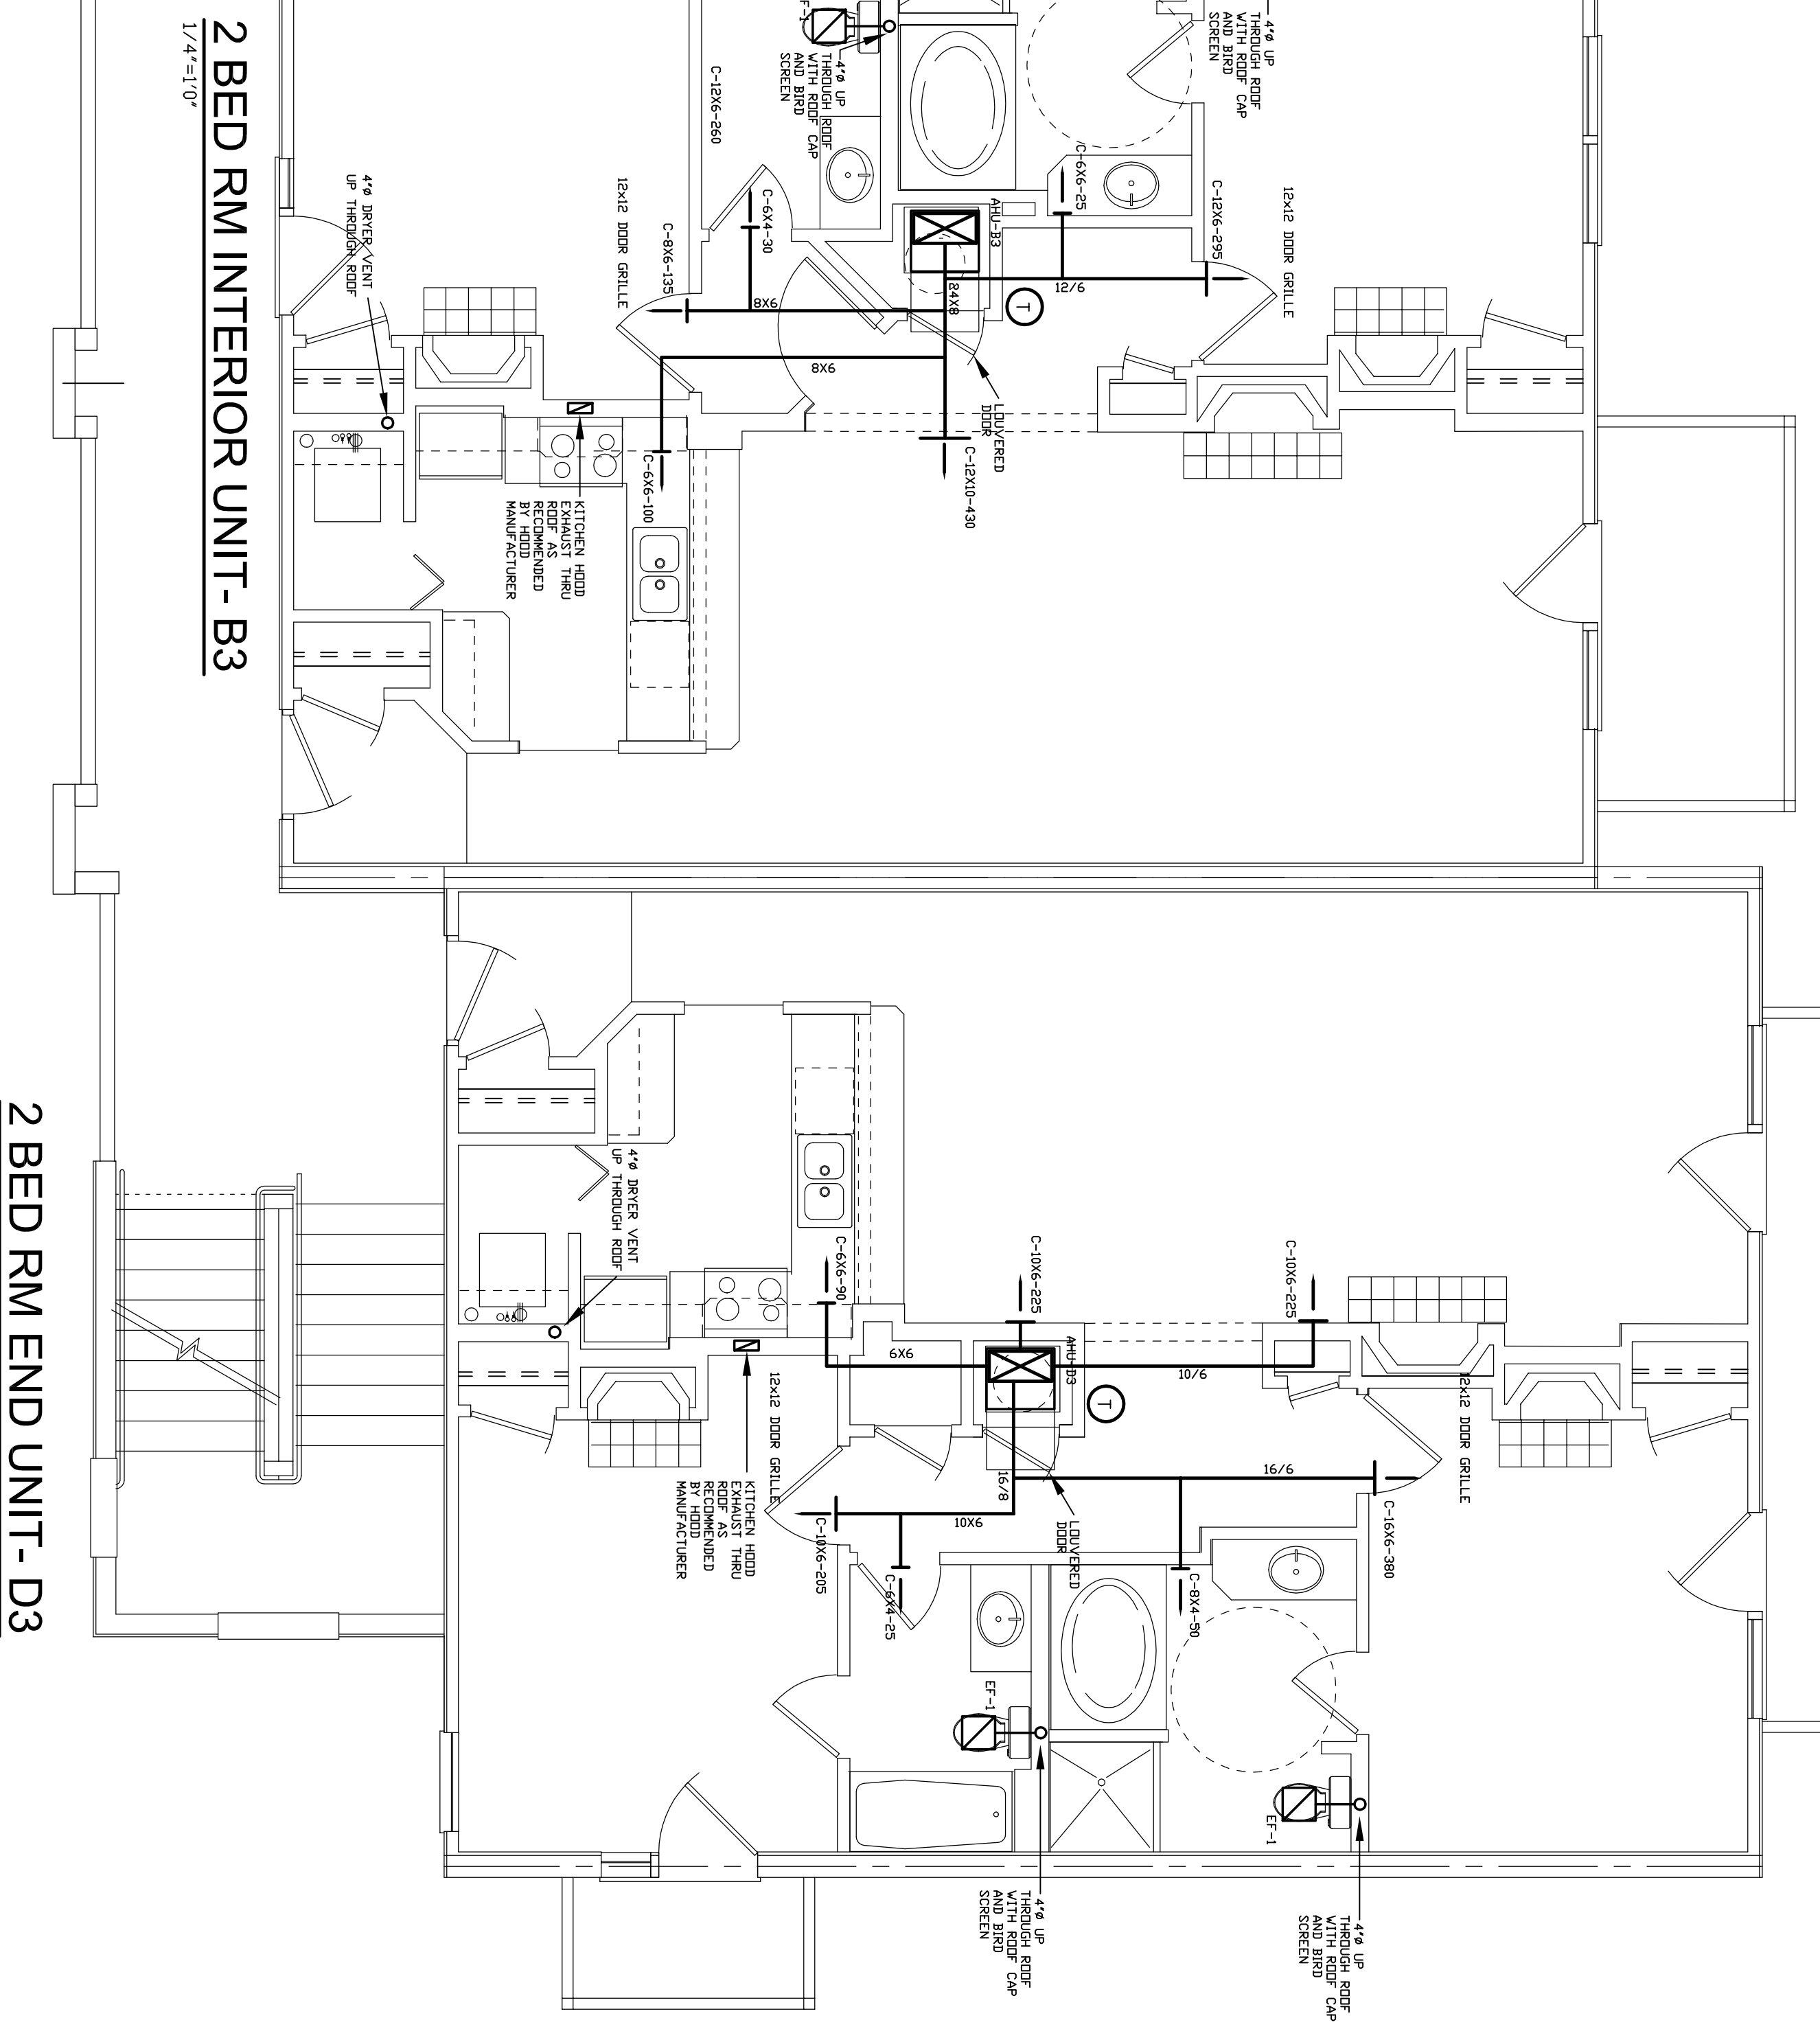

2 BED RM INTERIOR UNIT - B3
1/4"=1'0"

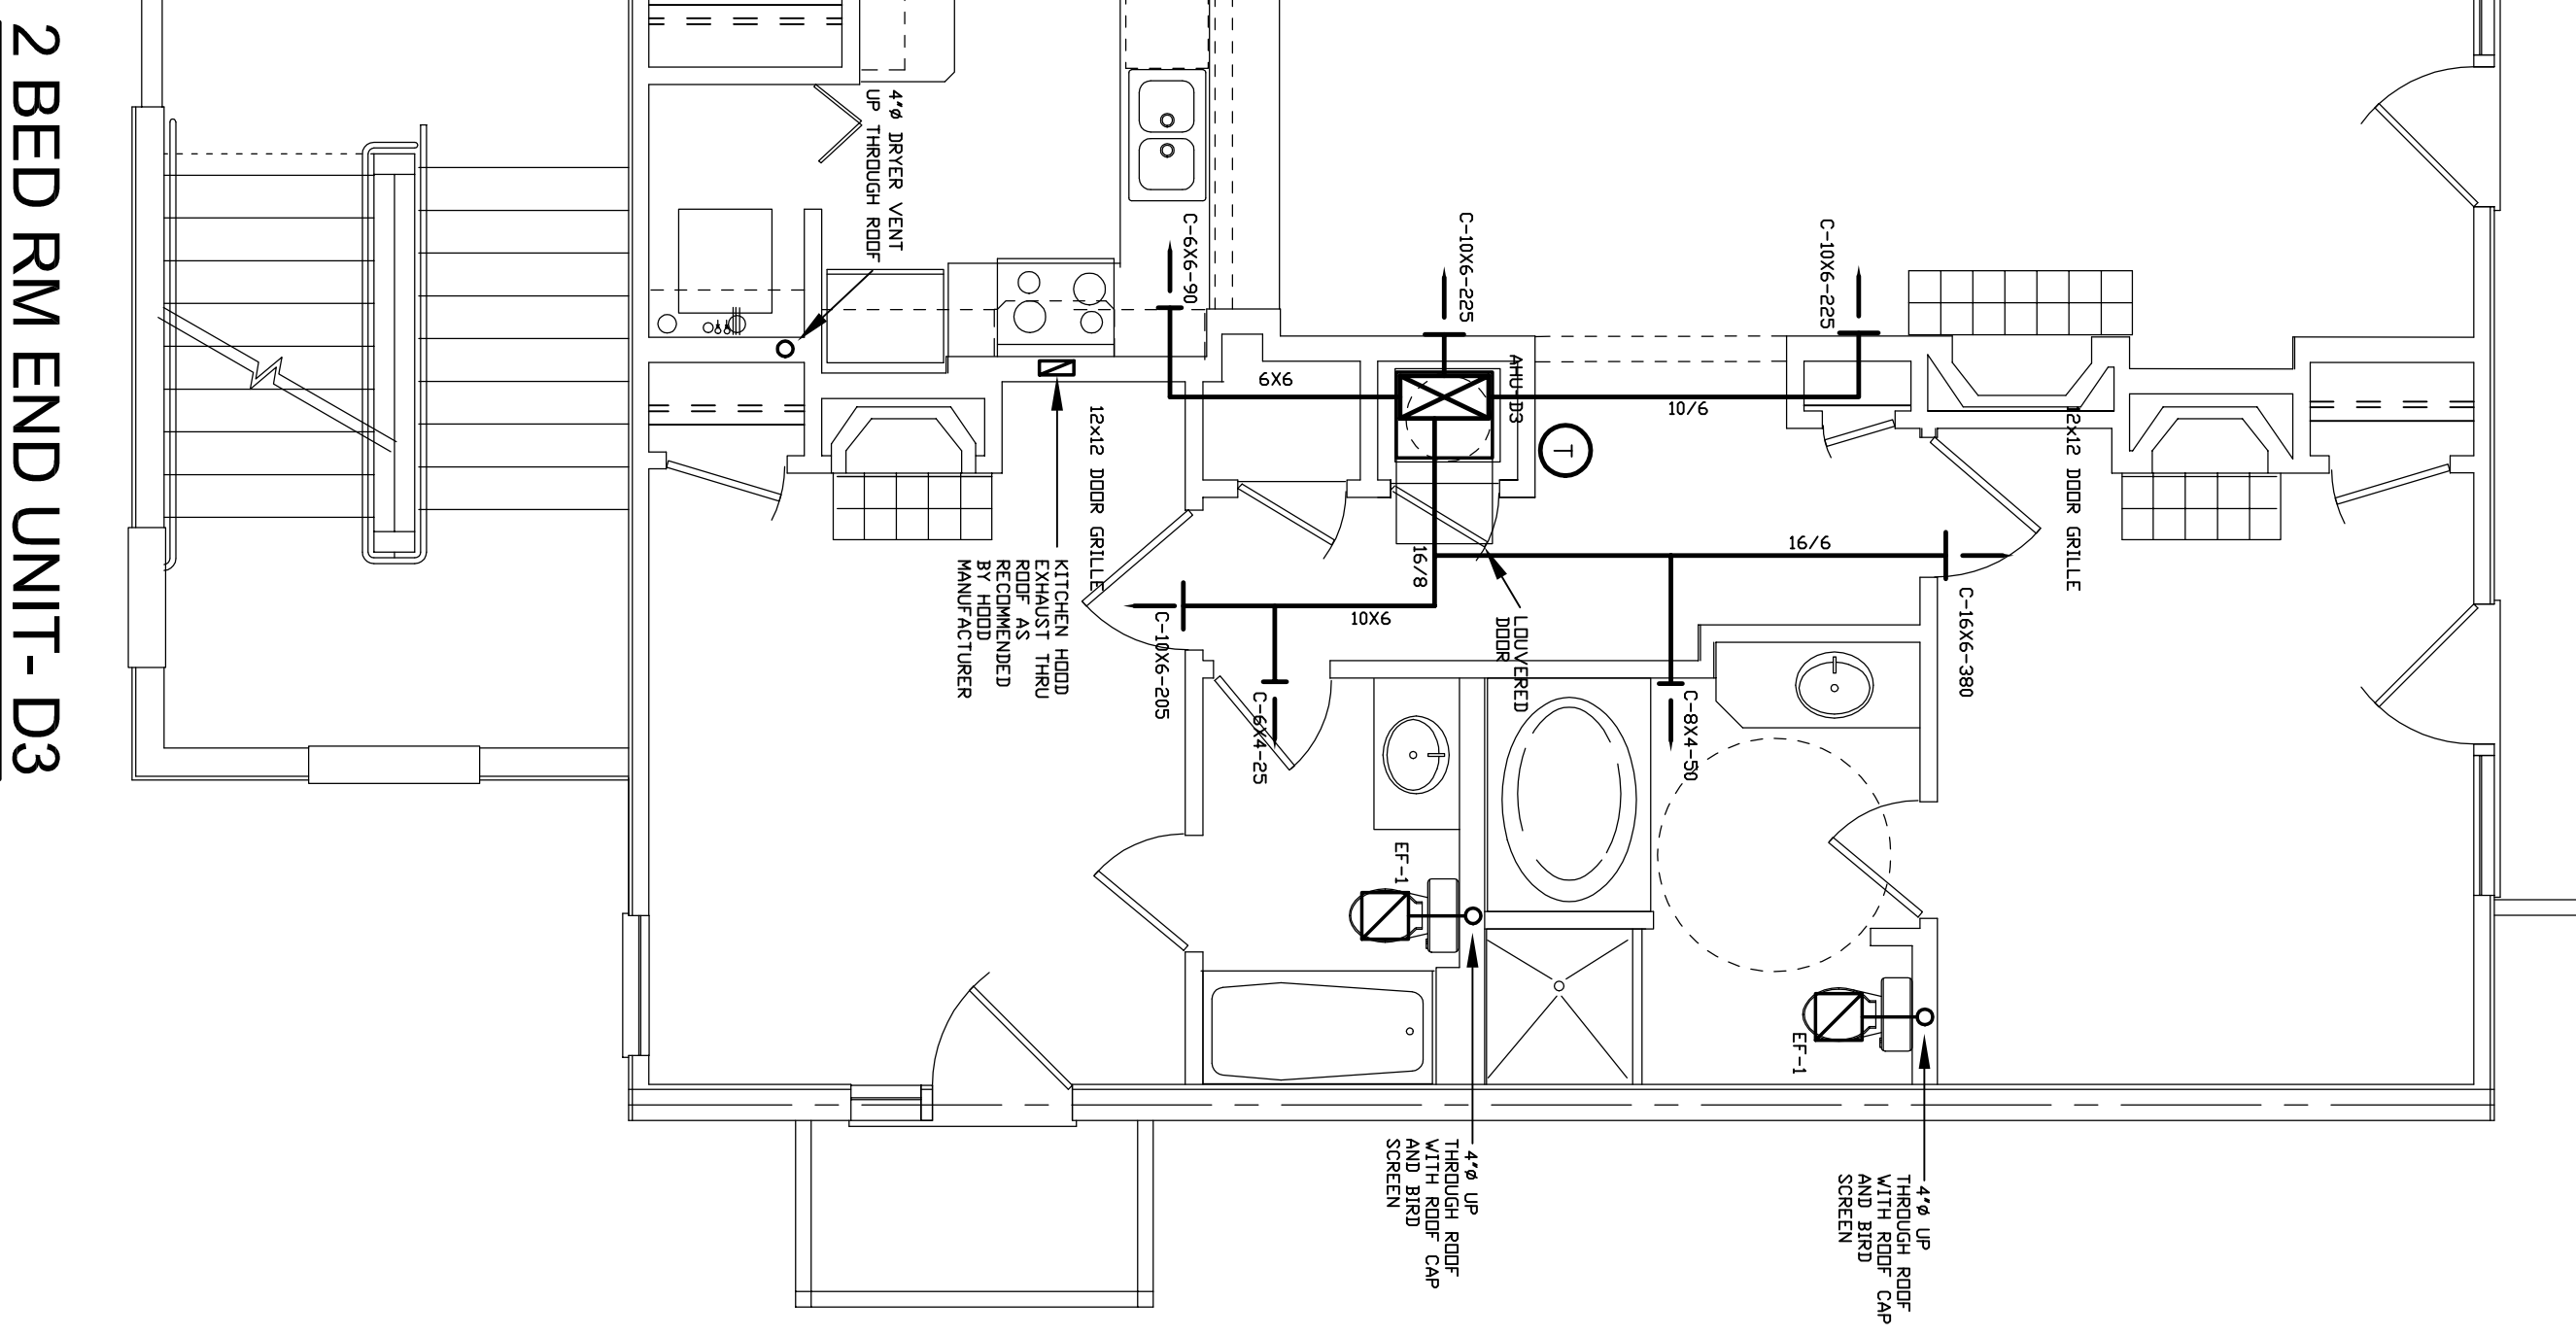

2 BED RM END UNIT - D3
1/4"=1'0"

THIRD FLOOR PLAN - HVAC
1/4"=1'0"

3RD FLOOR PLANS-HVAC

SHEET NO. **M-4**

DRAWN BY: _____

DATE: MAY 10, 2008

CHECKED BY: _____

JOB NO. _____

FOR: HABERSHAM CAPITAL ADVISORS, INC
MR. MICHAEL E. POU (404-233-3033)
3315 HABERSHAM ROAD N.W.
ATLANTA, GA 30305
CONTACT: JIM MASCHO (678-478-7235)

PROJECT: **HOFBRAUHAUS CONDOMINIUMS**
STATE ROUTE 17 & 75
HELEN, GEORGIA

L. DAVID HEWELL ARCHITECT
5600 ROSWELL RD. - PRADO MALL # M-180
SANDY SPRINGS, GEORGIA 30342

NO.	REVISIONS	DATE	BY
1			
2			
3			
4			
5			
6			
7			

